




LOCATION PLAN

Scale 1:1250

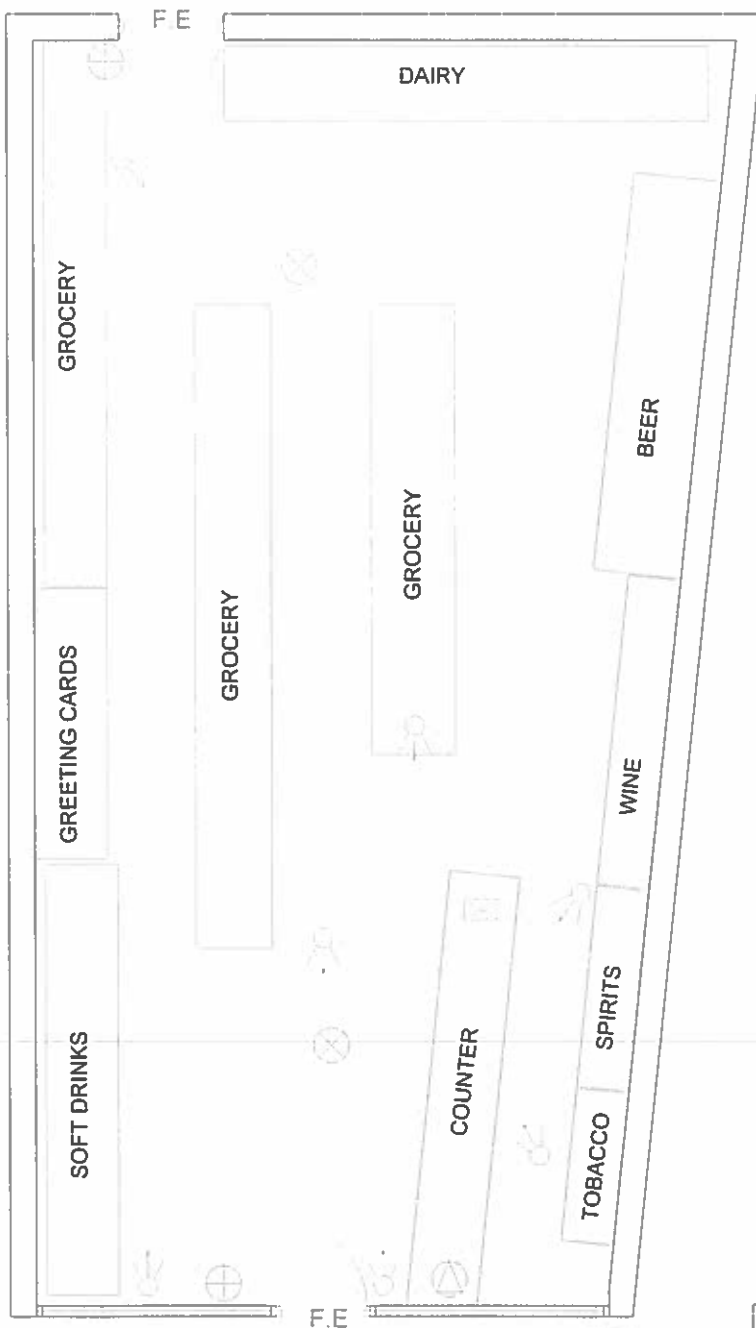

EXISTING SHOP FLOOR PLAN
Scale 1:50

KEYS:

F.E - Fire Exit

- Fire Alarm


- Smoke Detector

- Fire Extinguisher (Foam)

- Fire Extinguisher (H2O)

- CCTV

- First Aid equipment

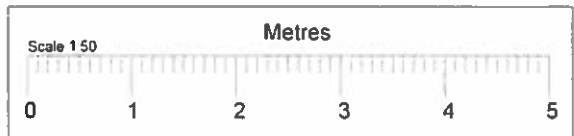


TITLE: PREMISES LICENCE

NAME MR T SHANMUGANATHAN

ADDRESS 01, SHAFTESBURY

PARADE SOUTH HARROW

 HA2 0AJ



Amendments

Notes:
 • This Drawing is Copyright of MKM DE SICIS
 • Contractor/Builder to check all dimension on site before commencement of any works. If quoted dimension (in any) is used.
 • All work shall comply with the latest Building Regulations & be to the satisfaction of the Local Authority.
 • Materials shall be suitable for the purpose for which they are used. The quality shall not be lower than that defined in the relevant British standard.
 Dwg No MKM/15/SHA01/PL00 Scale: SHOWN/A3 Dwn By: M MATHU Date: 27/10/2015 Page: 01/01