





LOCATION PLAN

Scale 1:1250

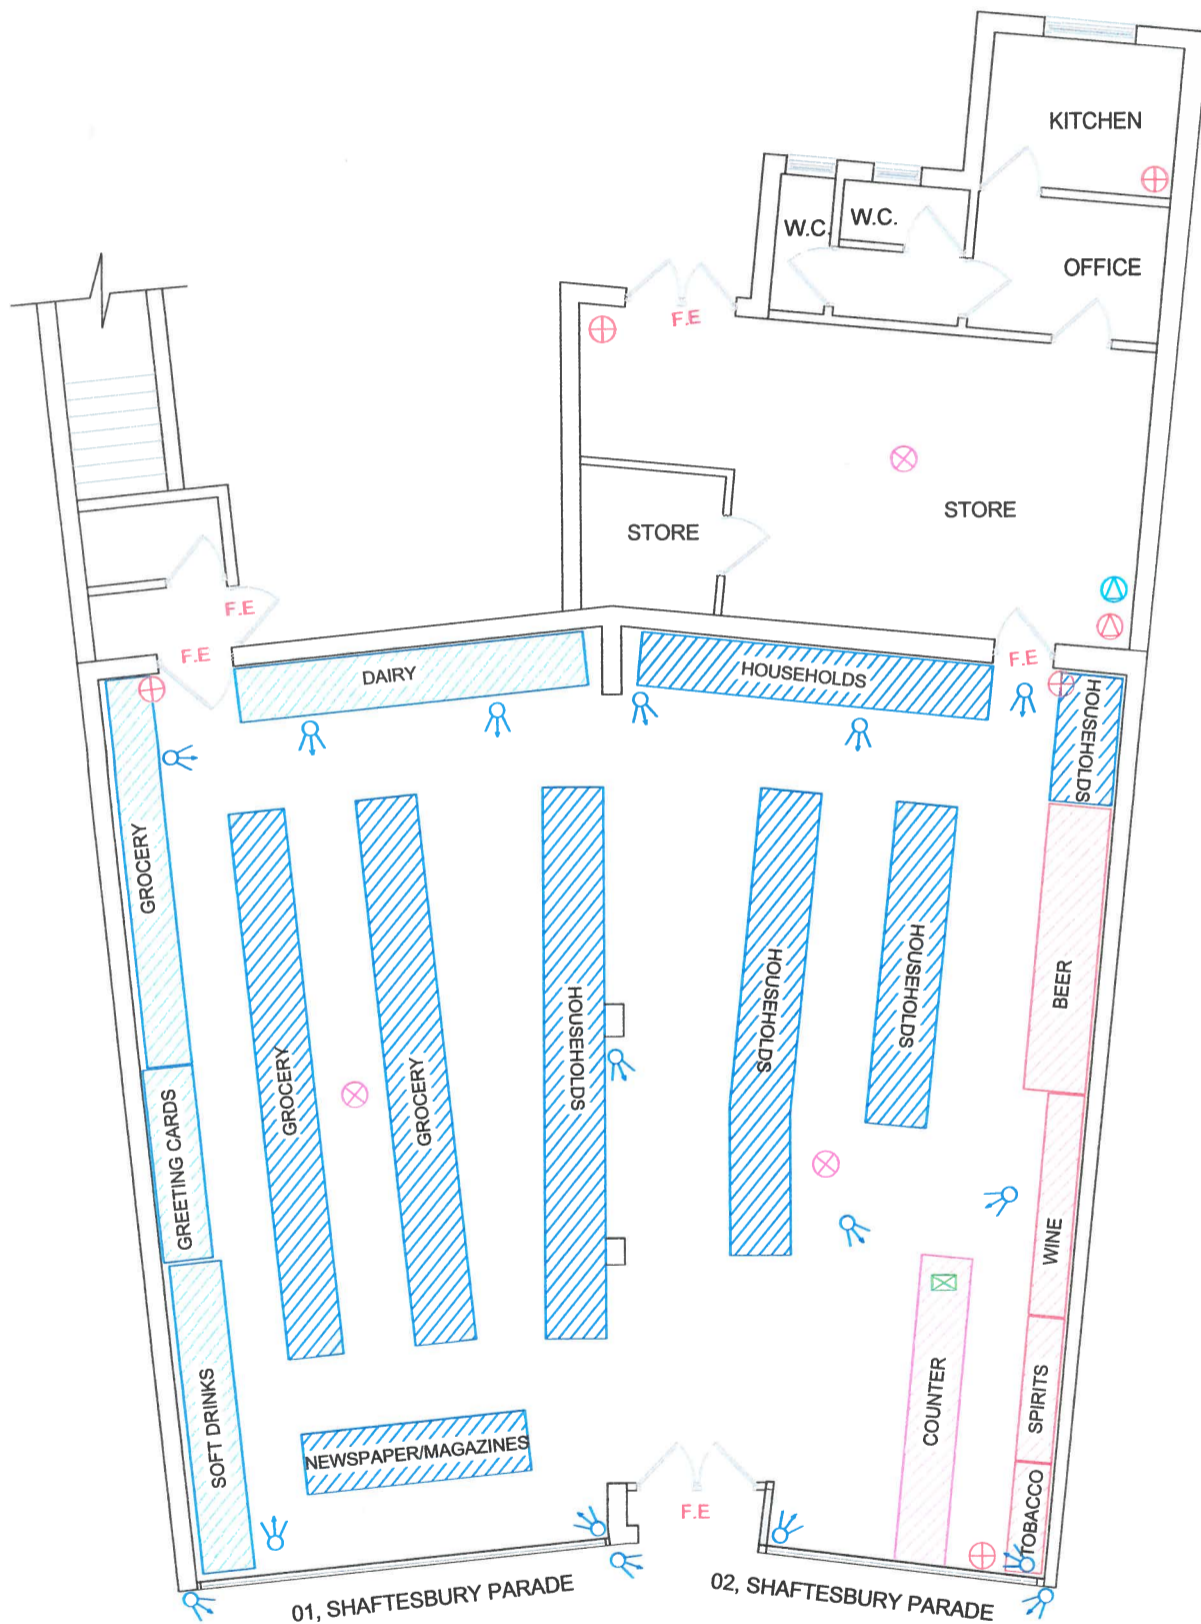

- KEYS:**
- F.E - Fire Exit
  - ⊕ - Fire Alarm
  - ⊗ - Smoke Detector
  - ⊖ - Fire Extinguisher (Foam)
  - ⊖ - Fire Extinguisher (H2O)
  - ⊖ - CCTV
  - ⊖ - First Aid equipment

PROPOSED SHOP FLOOR PLAN  
Scale 1:100

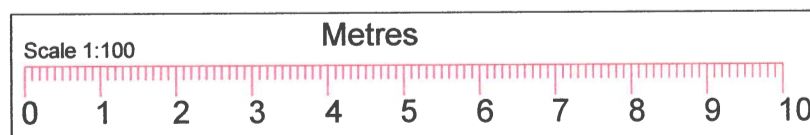

TITLE: PREMISES LICENCE

NAME : MR T.SHANMUGANATHAN  
ADDRESS : 01-02 SHAFTESBURY  
PARADE, HARROW  
HA2 0AJ

**MKM** DESIGN & CONSTRUCTION LTD

Contact: M.Mathu(BSc, MSc Civil Engineering)  
Tel : 07515365953 Web:mkmdesigns.co.uk  
Email: mathu\_eng@yahoo.co.uk

Amendments: -

Notes:  
# This Drawing is Copyright of MKM DESIGNS.  
# Contractor/Builder to check all dimension on site. Before commencement of any works. Figured dimension only to be used.  
# All work shall comply with the latest Building Regulations & be to the satisfaction of the L. Authority.  
# Materials shall be suitable for the purpose for which they are used & the quality shall not be lower than that defined in the relevant British standard.

Drg No : MKM/16/SH01-02/PL01 Scale : SHOWN@A3 Drwn By: M.MATHU Date : 05/08/2016 Page : 01/01