


Note :-


This drawing must not be scaled. All dimensions and levels must be checked on site and any discrepancies are to be reported to ARC DESIGN ASSOCIATES prior to manufacture.

NOTE.
The location and type of any fire safety and any other safety equipment is shown as at present. This may be varied from time to time with the agreement of the Fire Officer or after a fire risk assessment.
Anything shown on this plan, which is not required by the Plans Regulations for the Licensing Act 2003, is for illustrative purposes only and does not form part of the Licence.

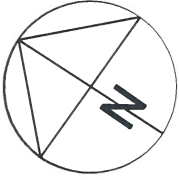

LEGEND

- Licensable Activities
- Fire Alarm Panel
 - Automatic fire detector
 - Manual Call Point
 - Sounder
 - Emergency light-fitting (fluorescent Downlight or luminaire)
 - Emergency Exit Light
 - Water fire extinguisher
 - Dry powder fire extinguisher
 - Carbon Dioxide fire extinguisher
 - Foam fire extinguisher
 - Push Bar to open

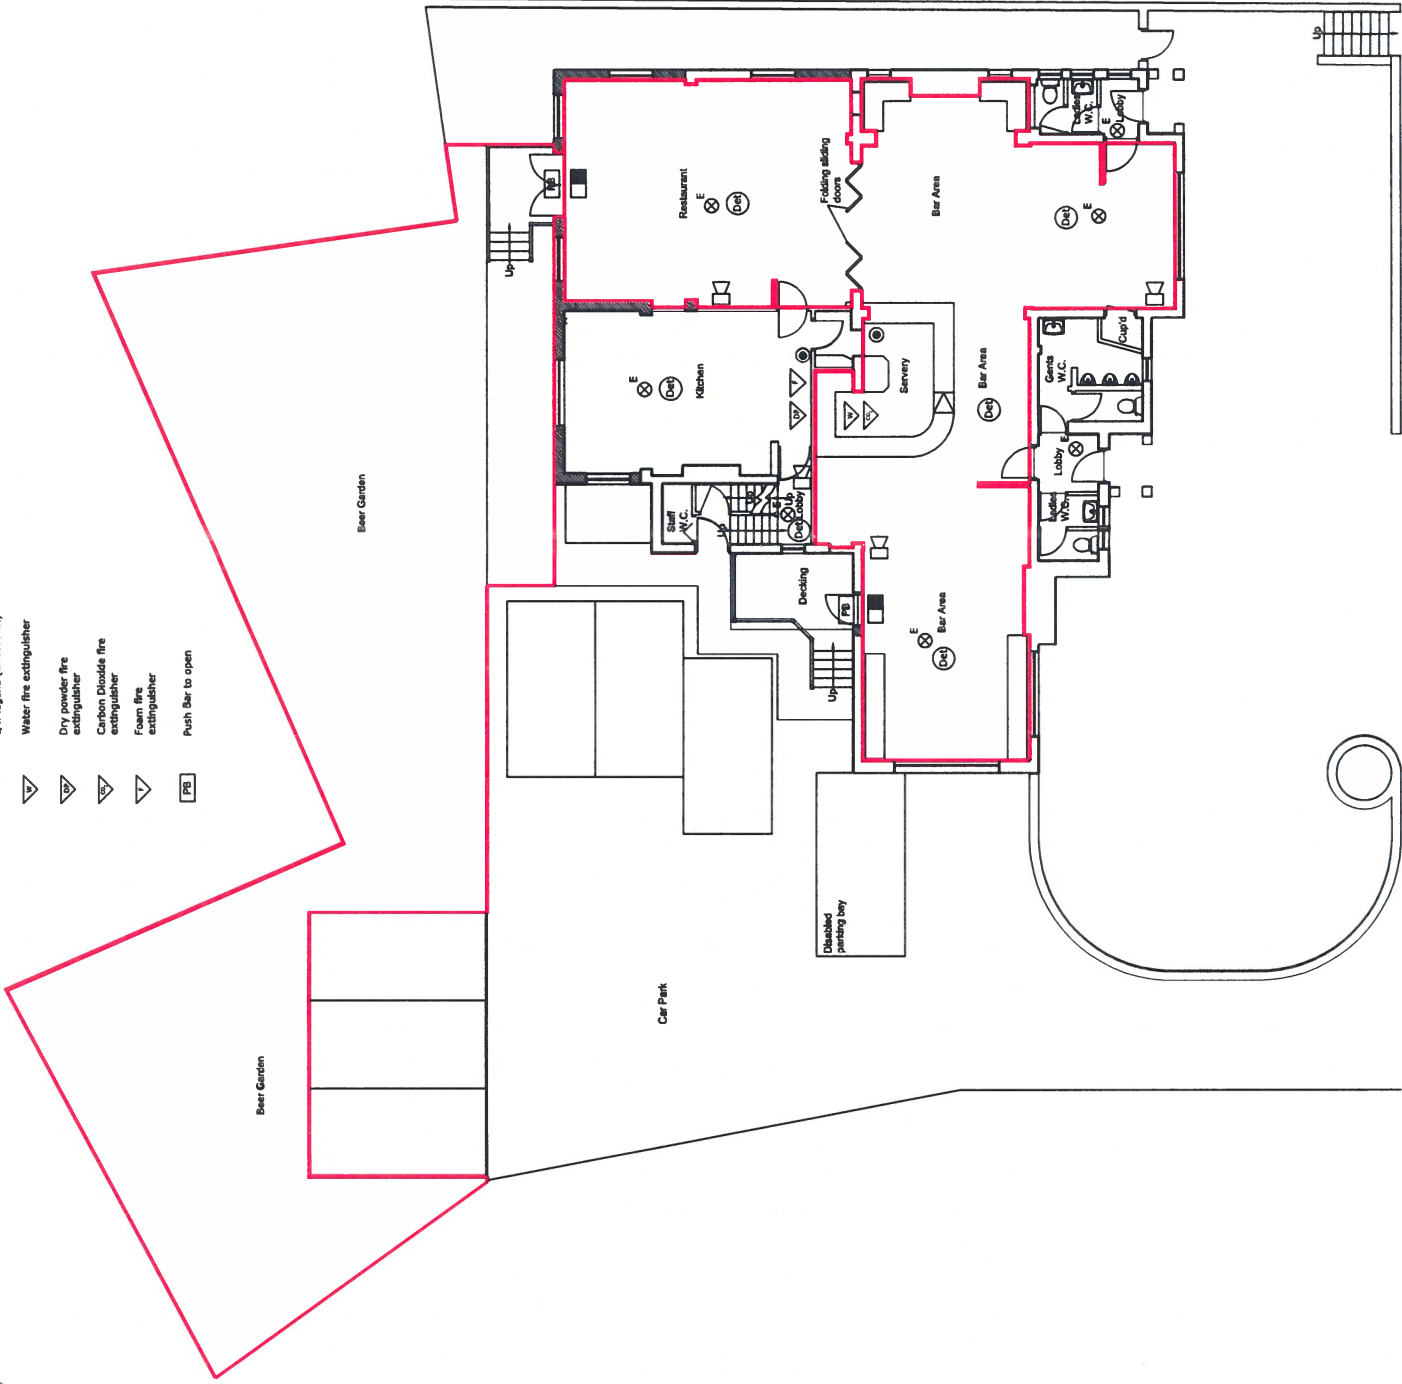

PROPOSED GROUND FLOOR PLAN

Rev Date

ARC
DESIGN
ASSOCIATES

51 - 55 Fowler Road
Hainault
Essex IG8 3XE
Tel : 020 8556 8666
Fax: 020 8556 8777

CLIENT
Fuller Smith & Turner PLC

PROJECT
White Horse
50, Middle Road
Harrow on the Hill

TITLE
Proposed Ground
Floor Plan

ISSUE
LICENSING

Scale: 1:100
Date: March 16
Drawn:
Rev.
Drawing No. 1942/LO1