


Contractors are to check all levels and dimensions before work is put in hand, and any discrepancies are to be referred to the architects

REV	DATE	DESCRIPTION	DWN	CHKD
-	00.00.00	-	-	-

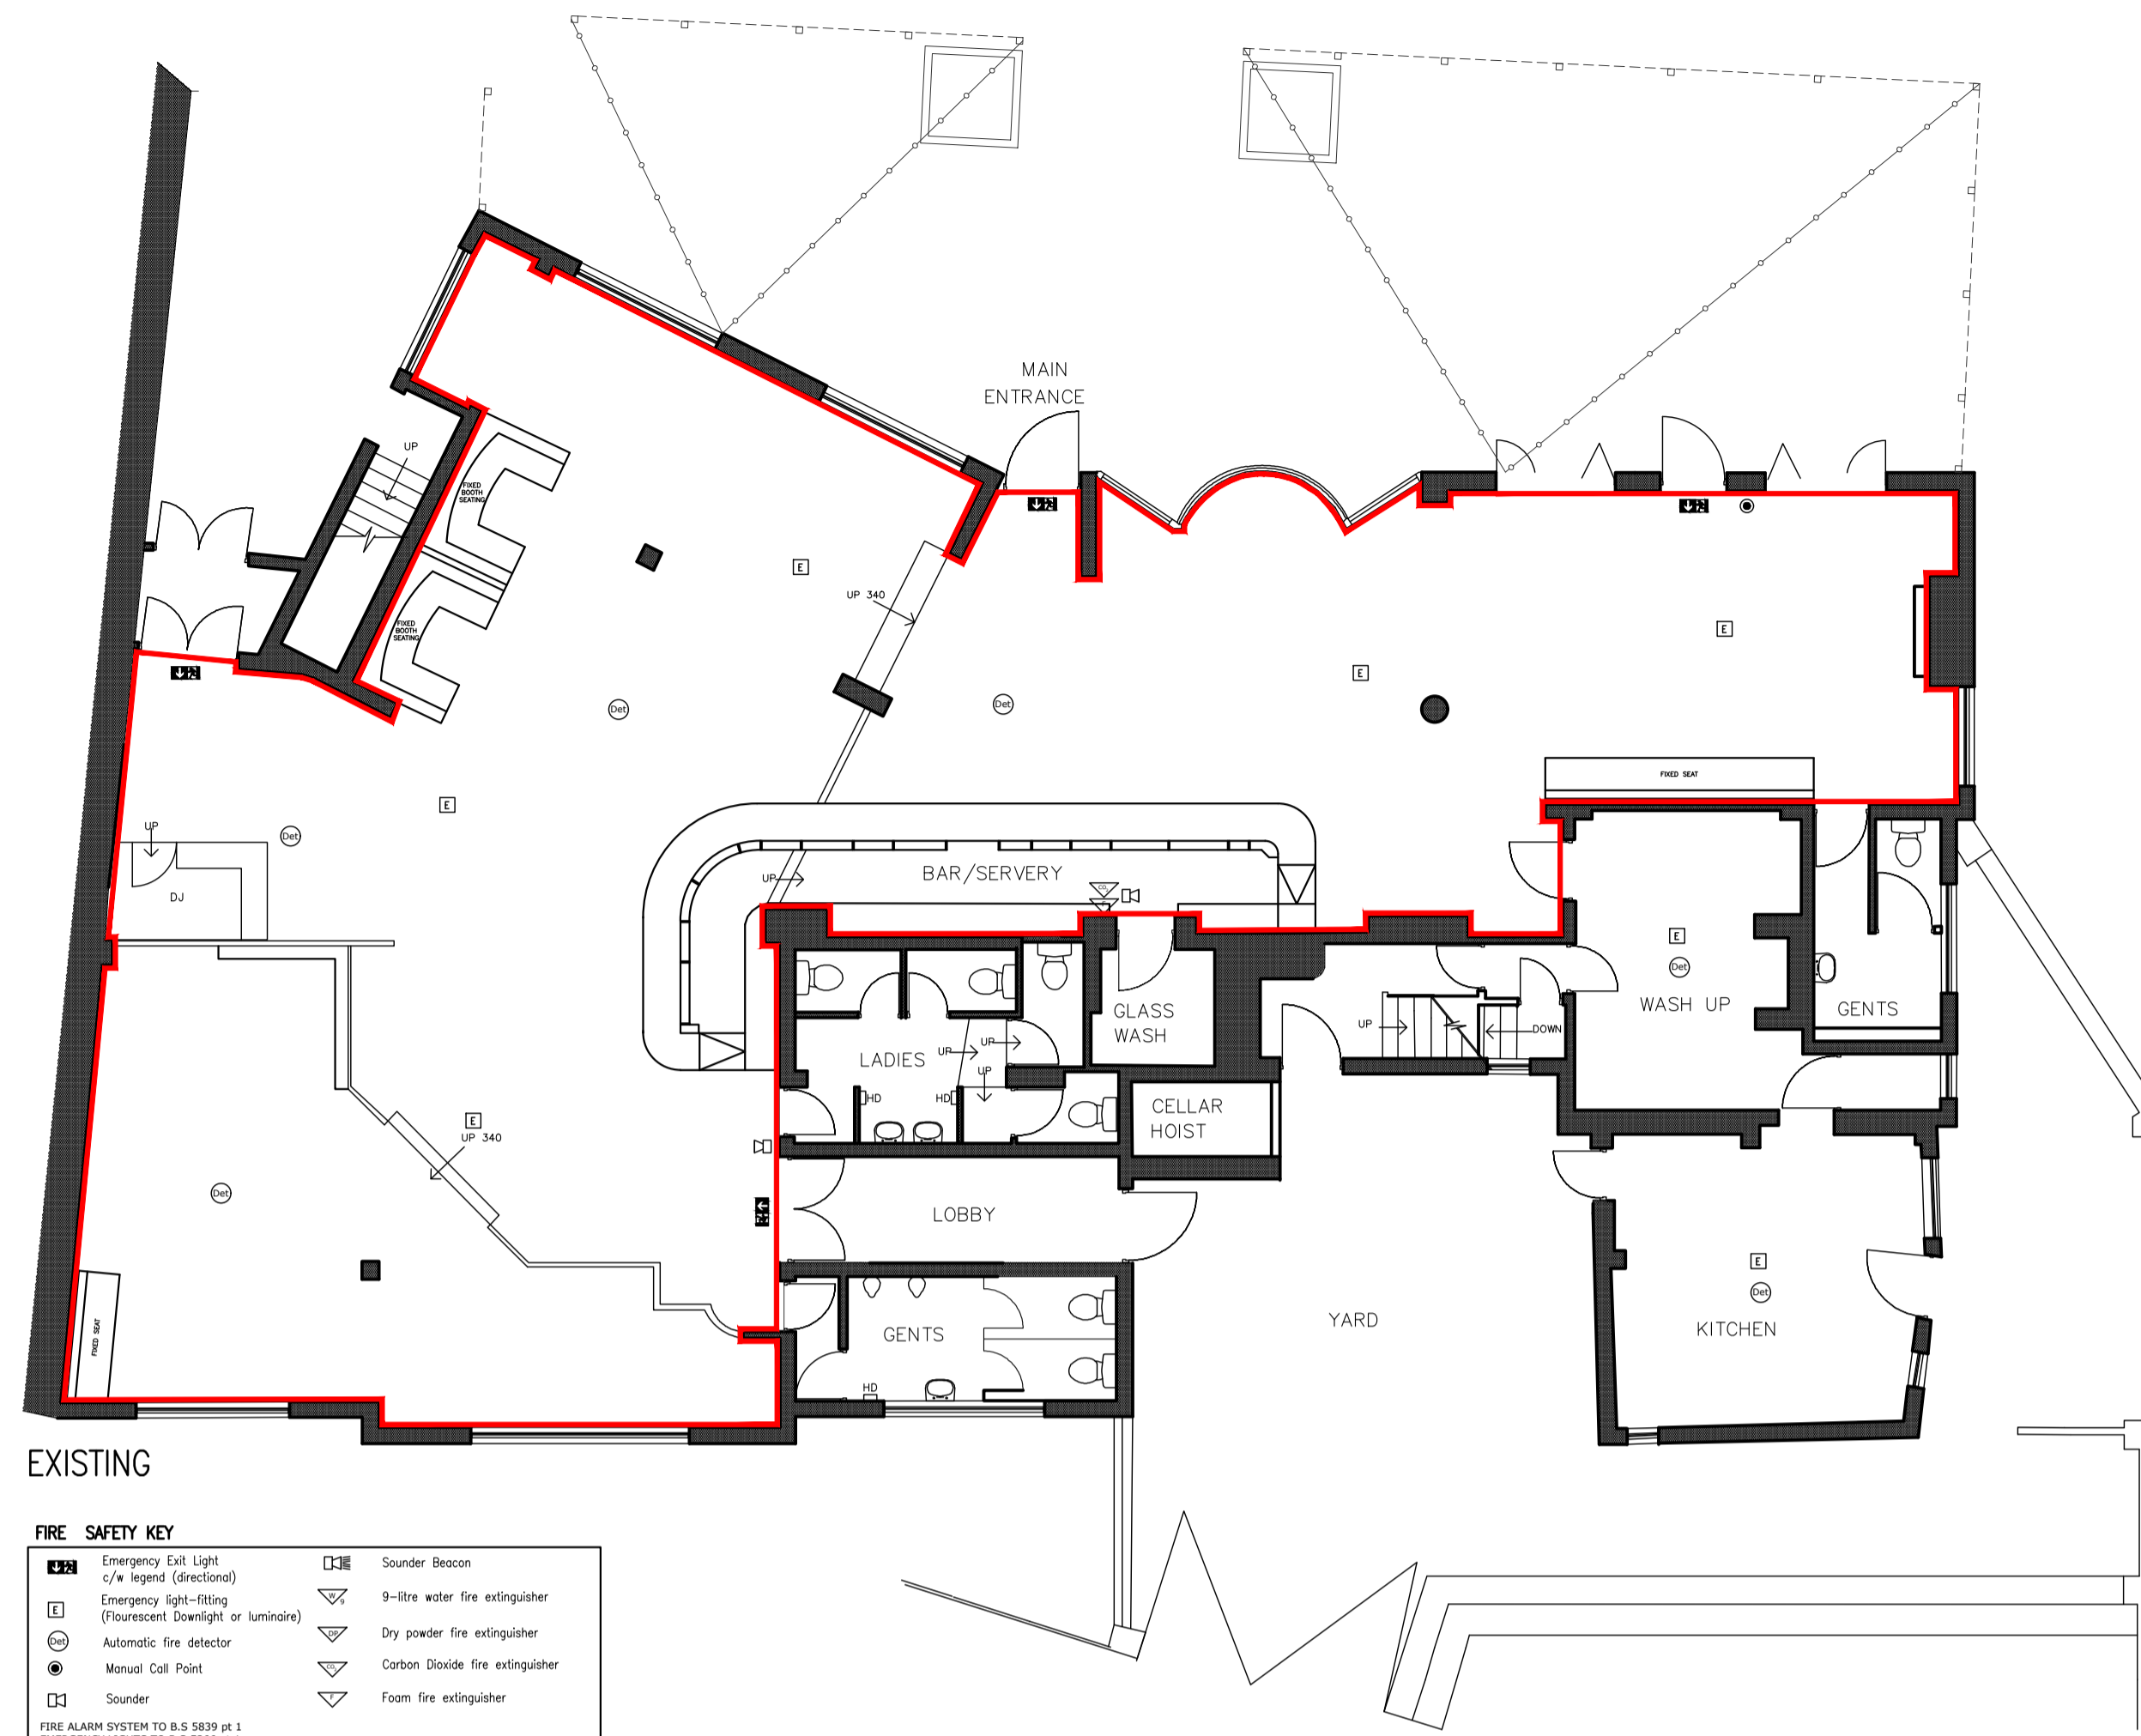

EXISTING


**FIRE SAFETY KEY**

	Emergency Exit Light c/w legend (directional)		Sounder Beacon
	Emergency light-fitting (Fluorescent Downlight or luminaire)		9-litre water fire extinguisher
	Automatic fire detector		Dry powder fire extinguisher
	Manual Call Point		Carbon Dioxide fire extinguisher
	Sounder		Foam fire extinguisher

FIRE ALARM SYSTEM TO BS 5839 pt 1  
EMERGENCY LIGHTS TO BS 5266 pt 1  
ILLUMINATED EXIT SIGNS TO BS 5499 pt 4

Area used for the site and occupation of  
buildings, the provision of fire risk assessment  
and the provision of regulated entertainment.

The location and type of any fire safety and any  
other safety equipment is shown on all drawings. This  
may be varied from time to time with the agreement  
of the fire officer or other a fire risk assessment.

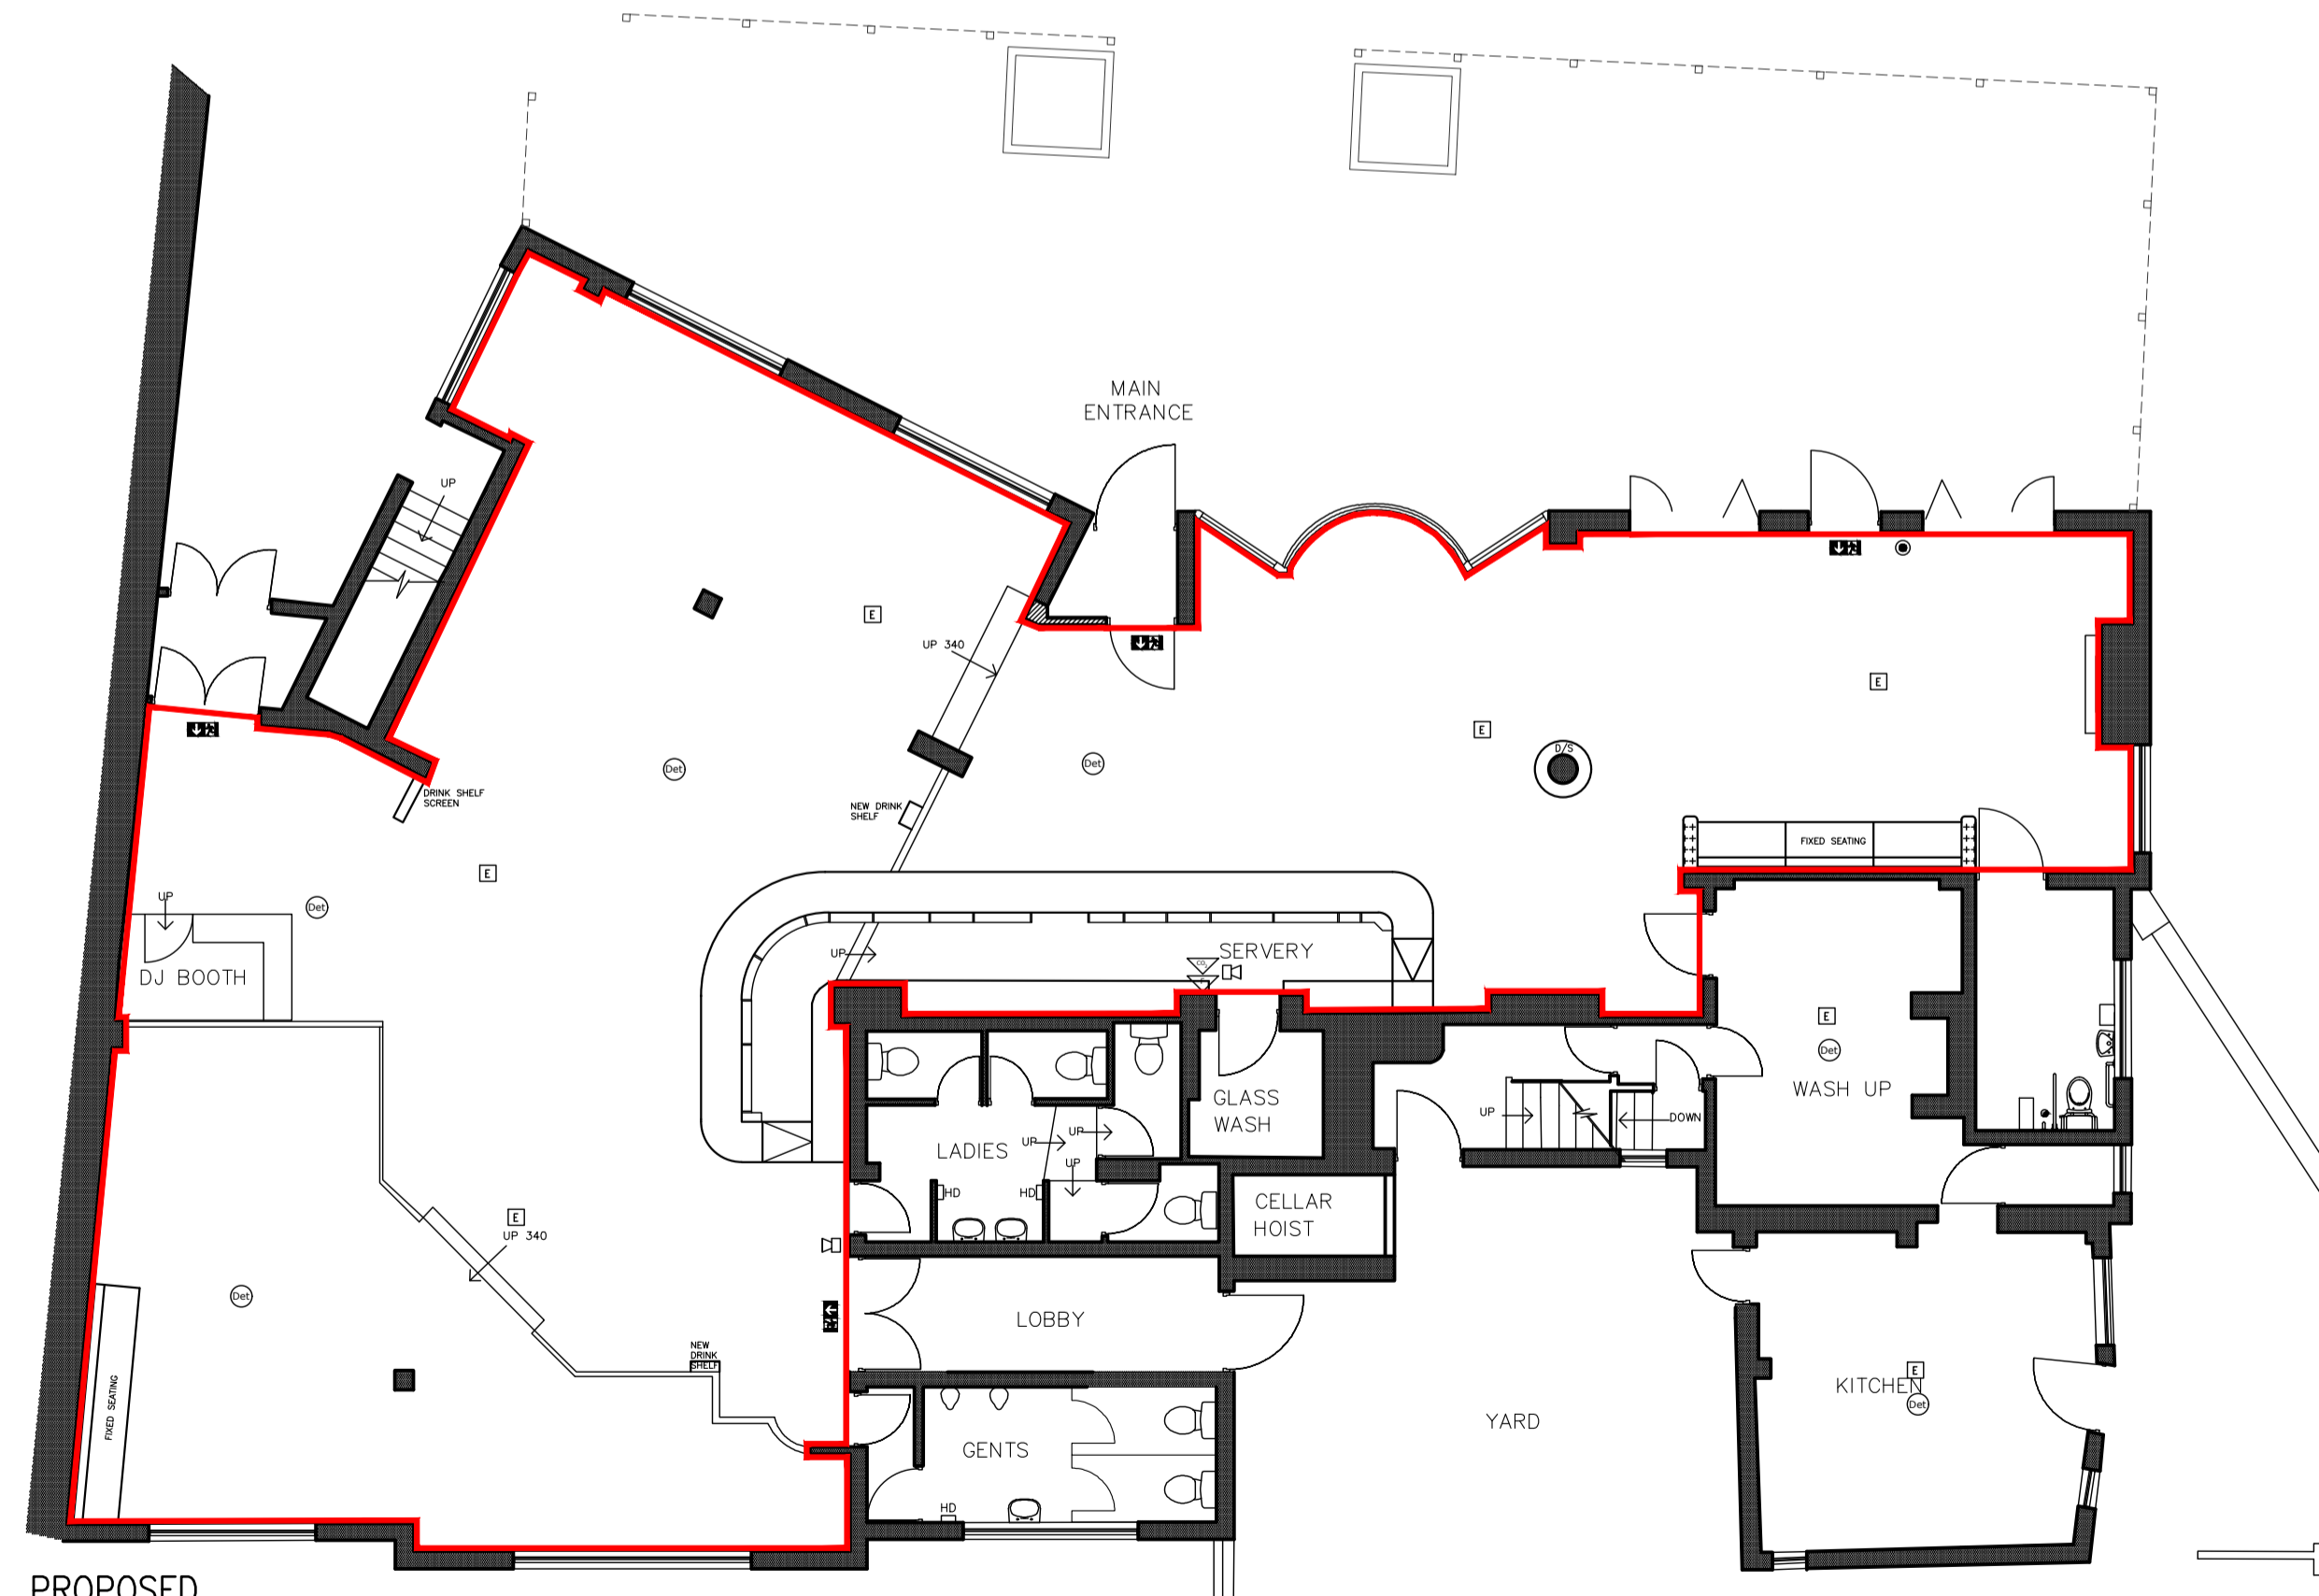

PROPOSED

**FIRE SAFETY KEY**

	Emergency Exit Light c/w legend (directional)		Sounder Beacon
	Emergency light-fitting (Fluorescent Downlight or luminaire)		9-litre water fire extinguisher
	Automatic fire detector		Dry powder fire extinguisher
	Manual Call Point		Carbon Dioxide fire extinguisher
	Sounder		Foam fire extinguisher

FIRE ALARM SYSTEM TO BS 5839 pt 1  
EMERGENCY LIGHTS TO BS 5266 pt 1  
ILLUMINATED EXIT SIGNS TO BS 5499 pt 4

Area used for the site and occupation of  
buildings, the provision of fire risk assessment  
and the provision of regulated entertainment.

The location and type of any fire safety and any  
other safety equipment is shown on all drawings. This  
may be varied from time to time with the agreement  
of the fire officer or other a fire risk assessment.



Architects + Interior Designers Limited  
123 NEW LONDON ROAD, CHELMSFORD,  
ESSEX, CM2 0QT  
TEL: +44 (0) 1245 269755 FAX: +44 (0) 1245 250310  
E-MAIL: admin@lap-architects.co.uk  
www.lap-architects.com

project

Royal Oak  
86 St Anns Road,  
Harrow, HA1 1JP

client

GREENE KING

drawing title

Existing & proposed  
Licensing Plans

drawing number	revision
8691 04	-
scale 1:100 @ A1	checked
drawn	date
	April 2018

This drawing is the property of LAP Architects + Interior Designers Ltd. and must not be copied or reproduced in any way in whole or in part without the express permission of LAP Architects + Interior Designers Ltd. Copyright © LAP Architects + Interior Designers Ltd.