


 








 

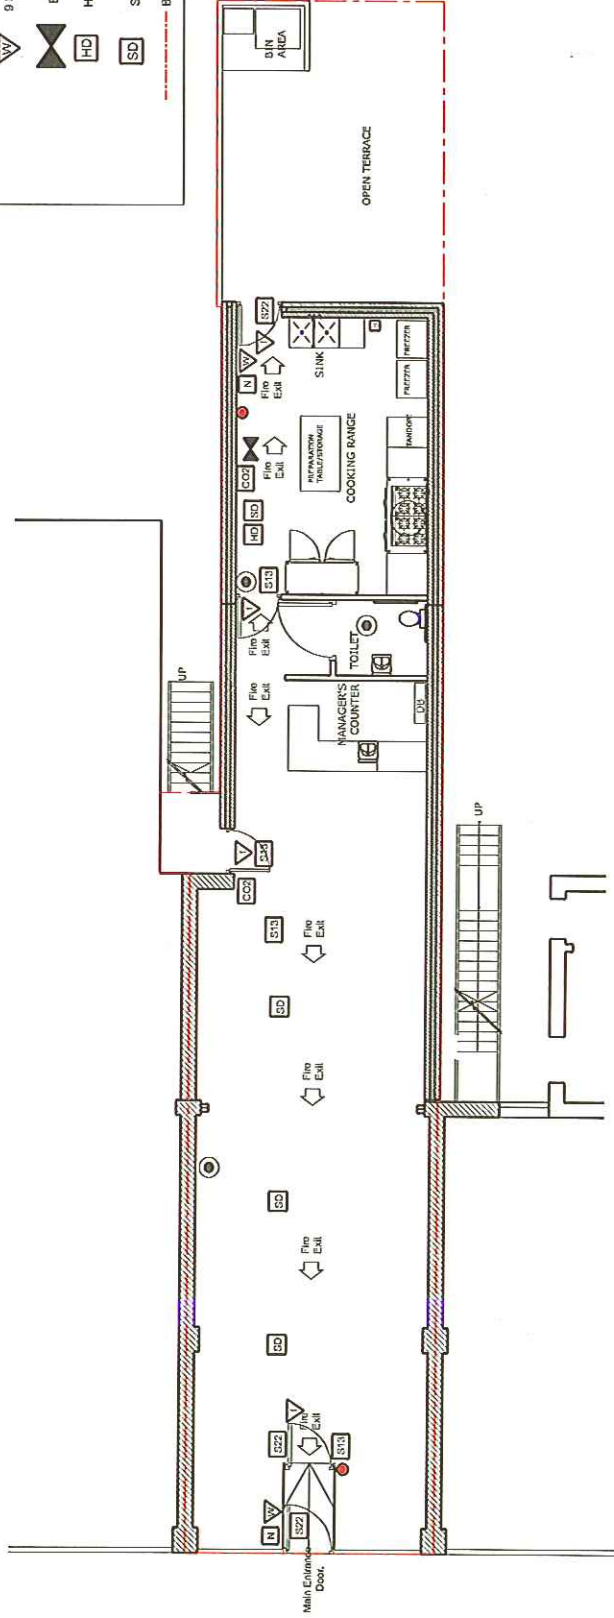


NOTES:

-  EMERGENCY LIGHT
-  FIRE ALARM CALL POINT.
-  FIRE EXIT - AND RUNNING MAN PICTOGRAM- WHITE LETTERS AND SYMBOLS ON A GREEN BACKGROUND.
-  FIRE DOOR KEEP SHUT
-  2 KG DRY POWDER EXTINGUISHER
-  2 KG CO₂ FIRE EXTINGUISHER.
-  FIRE INSTRUCTION NOTICE.
-  FIRE DOOR, FD30/S
-  FIRE BLANKET.
-  9 LITER WATER FIRE EXTINGUISHER.
-  ESCAPE LIGHTING
-  HEAT DETECTOR
-  SMOKE DETECTOR
-  BOUNDARY LINE



GROUND FLOOR PLAN

Note:
The area edged in **Red** on this plan indicates premises boundary.



ORIGINATOR  D FORM ARCHITECTURE 07924326055 www.dformarchitecture.co.uk	CLIENT EyeField Developments Limited	PROJECT TITLE 8 Village Way East, Harow, Middlesex HA2 7LU	DRAWING TITLE Premises Licence
		DRAWN BY: Anwar	CHECKED BY: Anwar
		SCALE 1:100 @ A3	DRAWING STATUS
		DATE Mar'14	DRAWING NO: 02
		REV:	

THE CONTENTS IN THIS DOCUMENT BELONG TO D FORM ARCHITECTURE LTD AND CANNOT BE ALTERED, COPIED, PRODUCED OR TRANSMITTED TO ANY OTHER PERSON OR COMPANY WITHOUT THE OWNER'S CONSENT.