








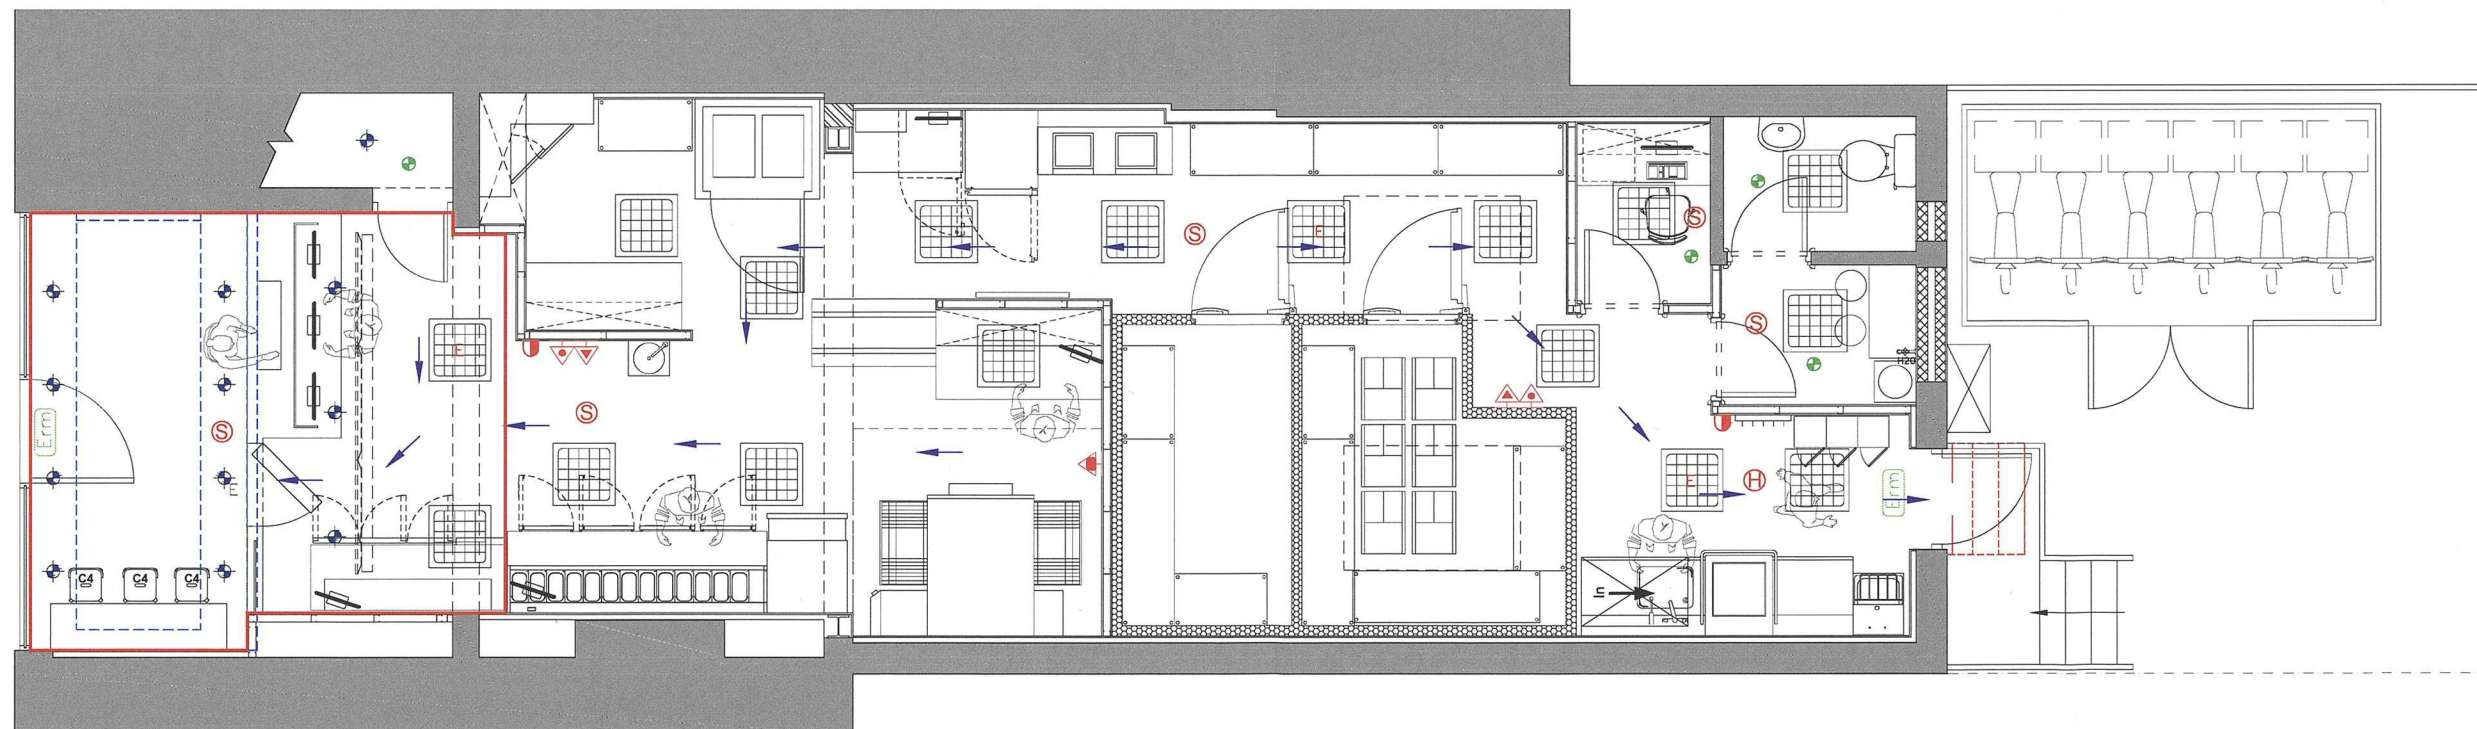
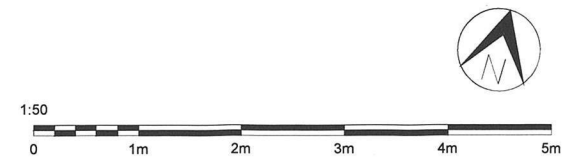


FIRE EQUIPMENT	
FIRE EXTINGUISHERS	
	Foam fire extinguisher
	CO2 fire extinguisher
FIRE DETECTION	
	Heat and smoke detectors. <i>Supplied by MC shopfitter</i> Note: Fire detection location is indicative. To be designed by approved installer. Fire alarm & detection system to be in accordance with BS 5839 part 1. If applicable, existing system to be protected and remain/modified to suit new layout.
	
FIRE BLANKET	
	Fire blanket
EMERGENCY EXIT SIGNAGE	
	Ceiling mounted maintained emergency exit sign with 3hr duration for interior environment (to BS 5499.).
STAFF ESCAPE ROUTE	
	Purple arrows denote staff escape route
EMERGENCY LIGHT	
	3hr maintained emergency pack
FIRE BREAK CALL POINT	
	Fire break call point



01 GROUND FLOOR PLAN
1:50



Scale: 1:50 @ A2
1:100 @ A4