


McCAFFERTY's 25 THE BROADWALK PINNER ROAD
 NORTH HARROW HA2 6ED
 LICENSING PLAN - SCALE 1:100 (A3) - DATE: 14 MAY 2018

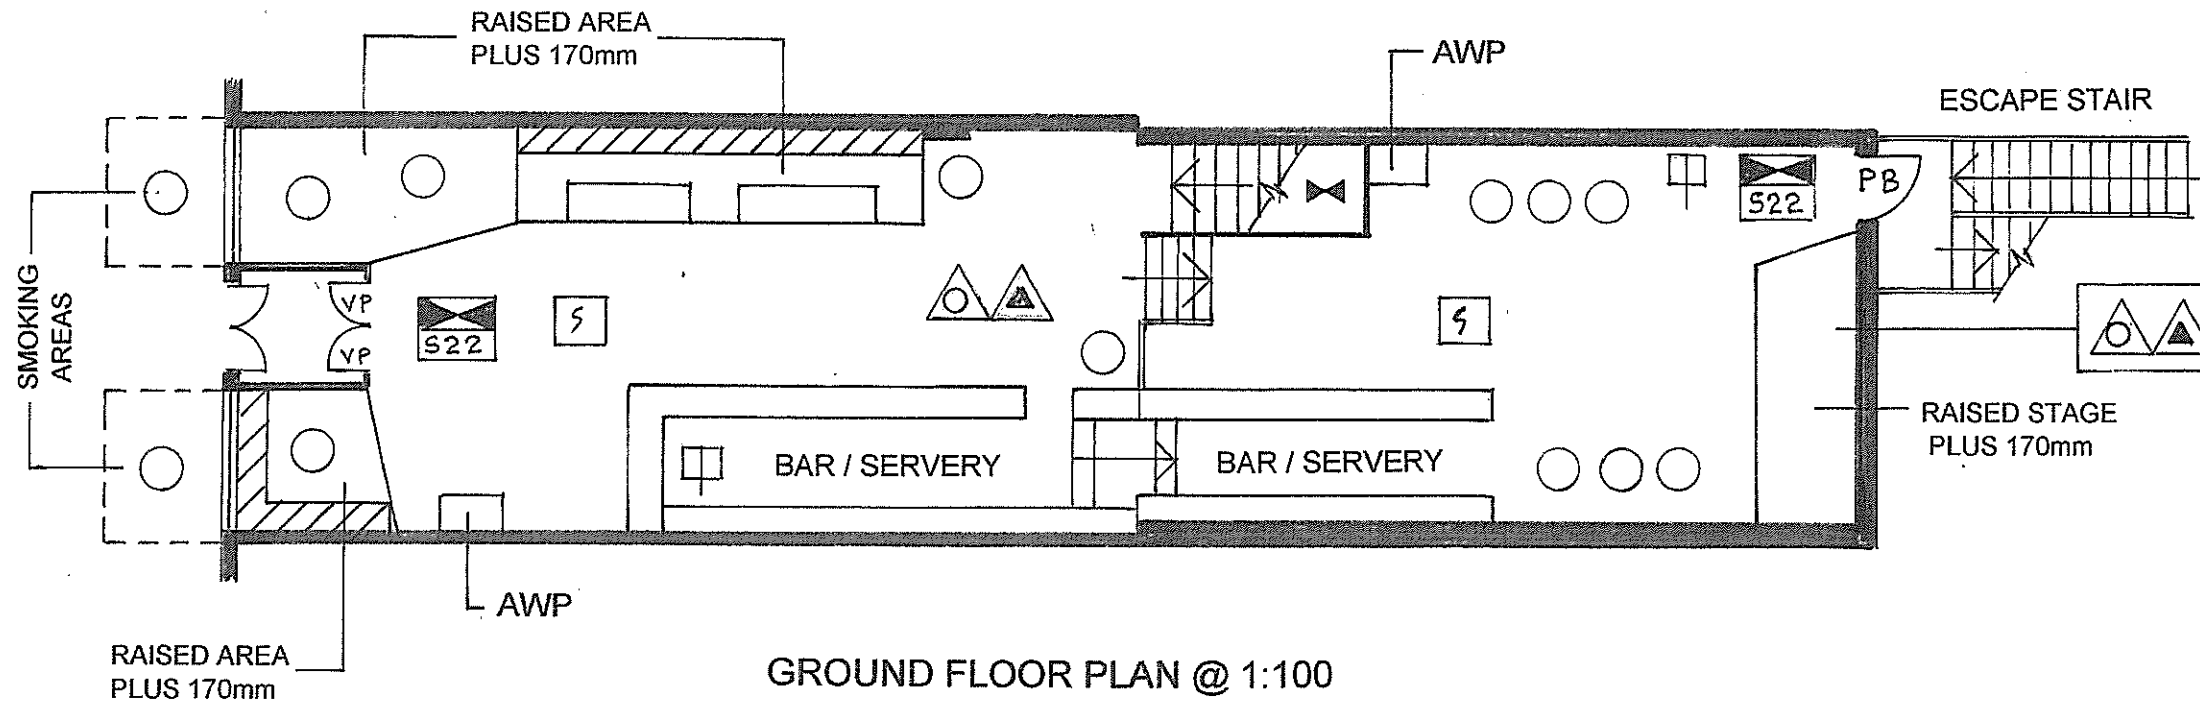

GROUND FLOOR PLAN @ 1:100

LEGENDS


	FIRE ALARM CALL POINT		ALARM SOUNDER / SIREN
PB	DOOR FITTED WITH PUSH BAR RELEASE		EMERGENCY LIGHTING
SF	DOOR WITH ONLY SIMPLE FASTENING		PERMANENTLY ILLUMINATED EMERGENCY LIGHT
FFF	DOOR FREE FROM LOCKABLE FASTENINGS	NOTICES:-	
VP	VISION PANEL	S22	FIRE EXIT OR EMERGENCY EXIT
	WATER EXTINGUISHER	S22	AS ABOVE BUT SUSPENDED ABOVE HEAD HEIGHT
	FOAM EXTINGUISHER	S20	FIRE ESCAPE KEEP CLEAR
	Co2 EXTINGUISHER	S2	NO SMOKING
	DRY POWDER EXTINGUISHER	S13	FIRE DOOR KEEP SHUT
	HYDRAULIC HOSE REEL	S14	FIRE DOOR KEEP LOCKED SHUT
	FIXED EXTINGUISHER INSTALLATION	OTHER	
	SPRINKLER SYSTEM	TABLES	
K	HEAT DETECTOR	FIXED SEATING	
S	SMOKE DETECTOR		
	FIRE BLANKET IN CONTAINER		

GENERAL NOTES

1. ARROWS ON STAIRS DENOTE UPWARD TRAVEL.
2. CCTV SURVEILLANCE SYSTEM INSTALLED.
3. FRONT ENTRANCE DOORS FIXED IN THE OPEN POSITION WHEN OPEN TO THE PUBLIC.

PDS
LICENSING

48 Greenford Gardens
 Greenford Middlesex UB6 9LZ
 Telephone/Fax: 020 8578 0155
 Mobile: 07976 510827

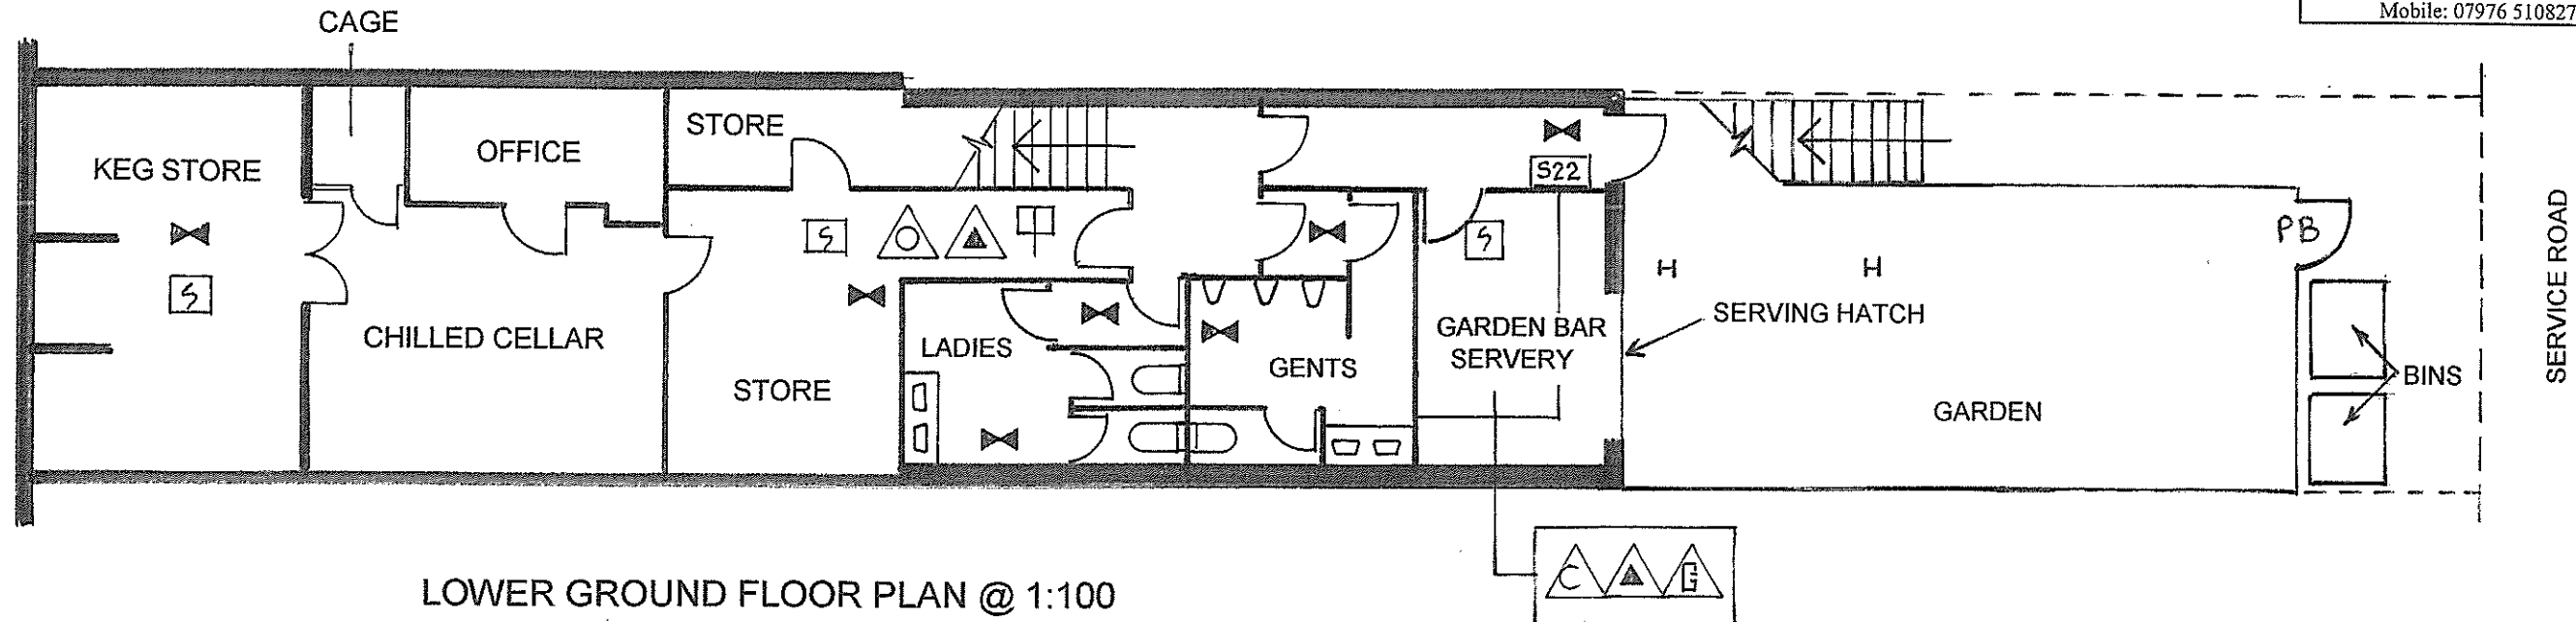

LOWER GROUND FLOOR PLAN @ 1:100