


PLAN 1 of 2

SCALE BAR 10m @ 1:100

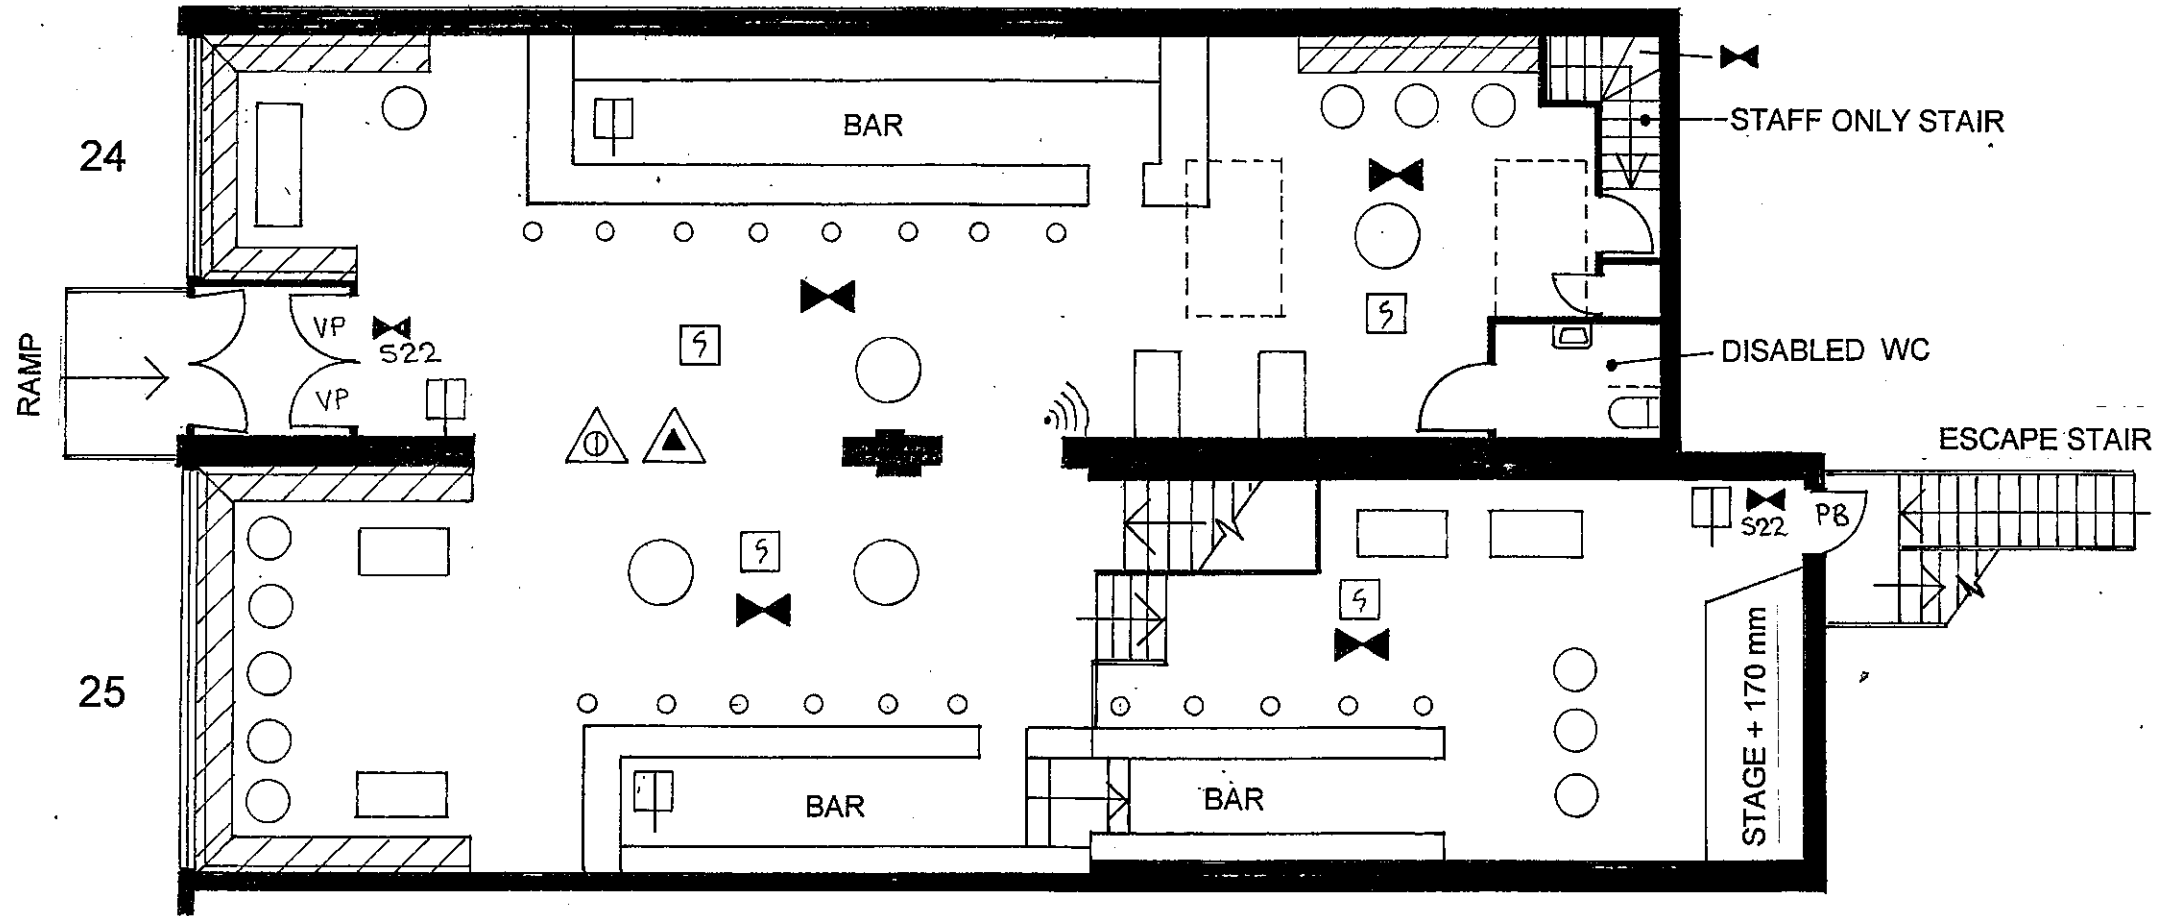

GROUND FLOOR PLAN @ 1:100

	FIRE ALARM CALL POINT		ALARM SOUNDER / SIREN
PB	DOOR FITTED WITH PUSH BAR RELEASE		EMERGENCY LIGHTING
SF	DOOR WITH ONLY SIMPLE FASTENING		PERMANENTLY ILLUMINATED EMERGENCY LIGHT
FFF	DOOR FREE FROM LOCKABLE FASTENINGS	<b>NOTICES:-</b>	
VP	VISION PANEL	S22	FIRE EXIT OR EMERGENCY EXIT
	WATER EXTINGUISHER	S22	AS ABOVE BUT SUSPENDED ABOVE HEAD HEIGHT
	FOAM EXTINGUISHER	S20	FIRE ESCAPE KEEP CLEAR
	Co2 EXTINGUISHER	S2	NO SMOKING
	DRY POWDER EXTINGUISHER	S13	FIRE DOOR KEEP SHUT
	HYDRAULIC HOSE REEL	S14	FIRE DOOR KEEP LOCKED SHUT
	FIXED EXTINGUISHER INSTALLATION		<u>OTHER</u>
	SPRINKLER SYSTEM		FIXED SEATING
	HEAT DETECTOR		LOOSE TABLES
	SMOKE DETECTOR		
	FIRE BLANKET IN CONTAINER		



McCAFFERTY'S  
24 - 25 BROADWALK  
PINNOR ROAD  
NORTH HARROW  
HA2 6ED


LICENSING PLAN

SCALE 1:100  
Dwg No. 0219 DB 01

PLAN 2 of 2



SCALE BAR 10m @ 1:100

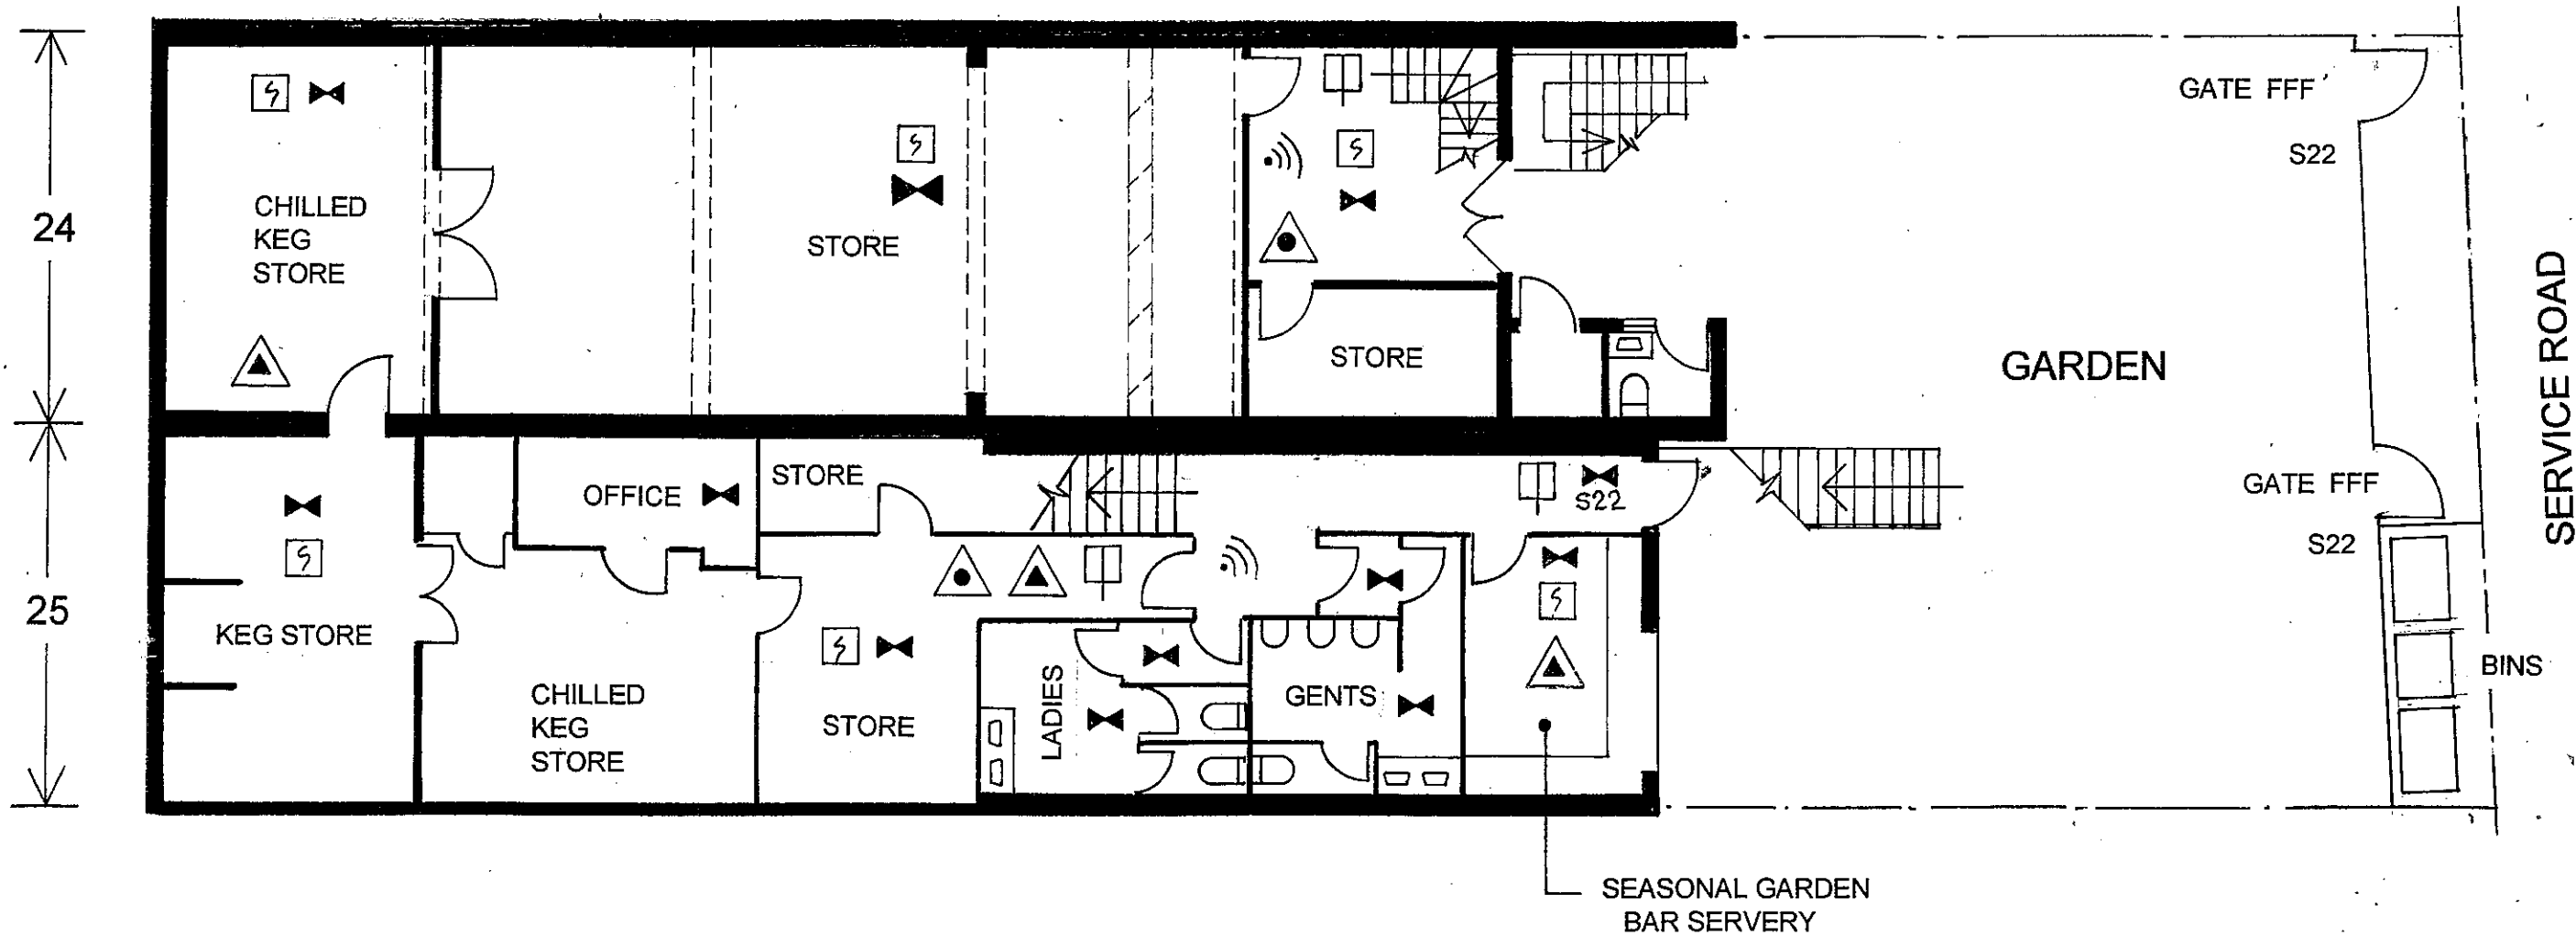

LOWER GROUND FLOOR PLAN @ 1:100



McCAFFERTY'S  
24 - 25 BROADWALK  
PINNOR ROAD  
NORTH HARROW  
HA2 6ED

LICENSING PLAN

SCALE 1:100  
Dwg No. 0219 DB 02