



LOCATION PLAN 1/1250

KEY

	FIRE EXIT SIGNAGE
	30 M MINUTES FIRE RESISTANT DOOR
	FOAM EXTINGUISHER 6L
	CO2 EXTINGUISHER 2kg
	FIRE BLANKET 1.2 X 1.2 M
	NON-MAINTAINED EMERGENCY LIGHTING
	FIRE ALARM CALL POINT
	GAS SHUT OFF VALVE
	SMOKE DETECTOR
	HEAT DETECTOR

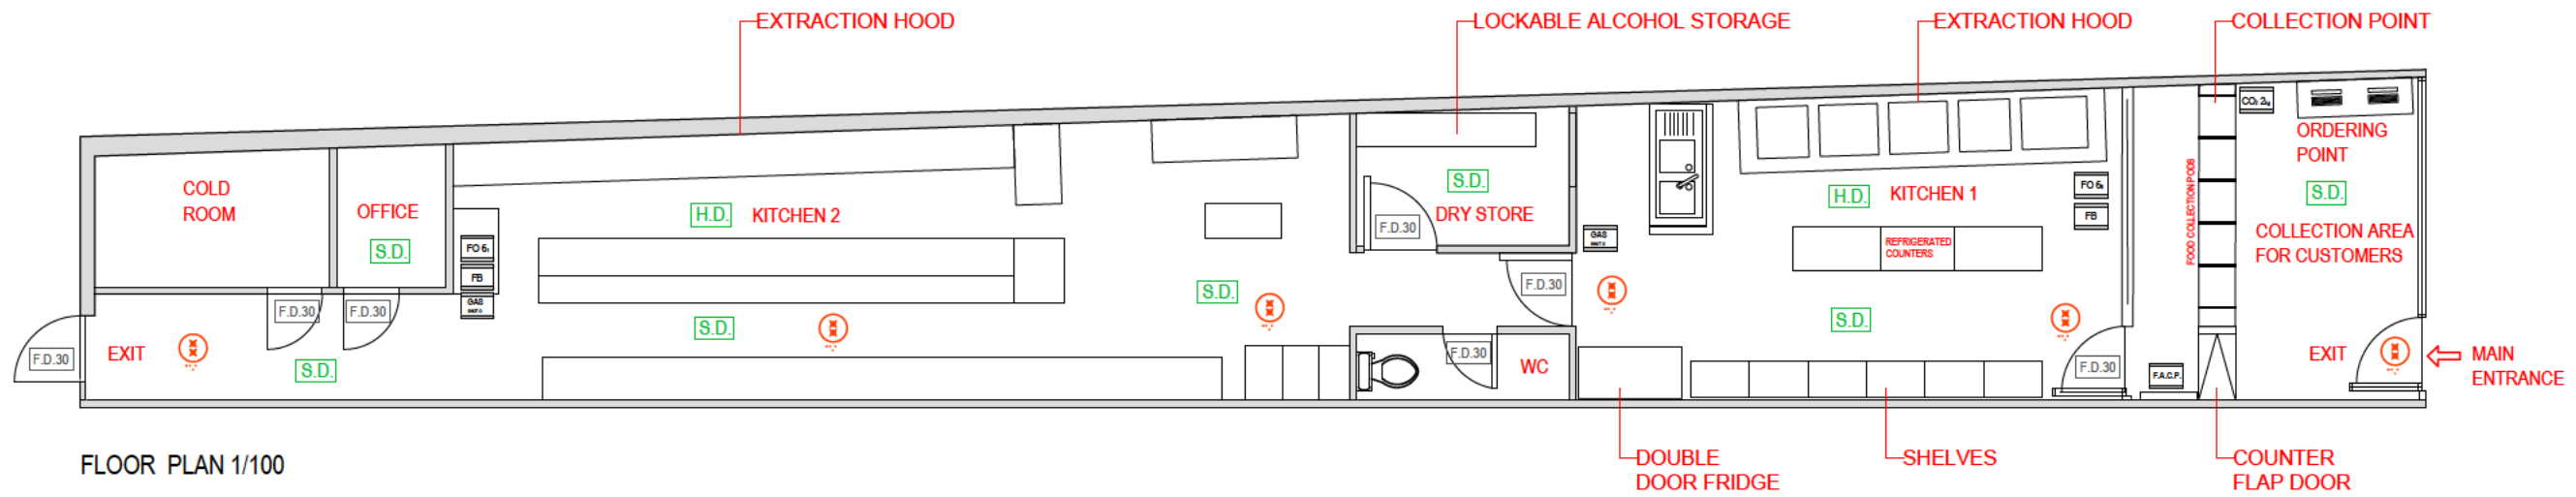

 FLOOR PLAN 1/100



PROJECT NAME PN FOOD LTD		
PROJECT STATUS FOR LICENCING	REVISION NR:	DATE: 2020-06-24
DESIGN BY	CLIENT PN FOOD LTD 110 Streatfield Road Streatfield, London SE13 5BT 020 3298 0888 info@pnfood.com	
DRAWING PROPOSED PLAN FOR LICENCING		
DRAWN BY:	SCALE: 1/100	PAGE SIZE: A3
DRAWING NUMBER: 110 01 100	REVISION:	/