


NOTES:
 All construction to comply with all relevant and current building regulations.
 For building regulation compliance please refer building regulation/ structural engineers drawing.
 All Dimensions to be measured by contractor on site prior to construction. Not for construction.

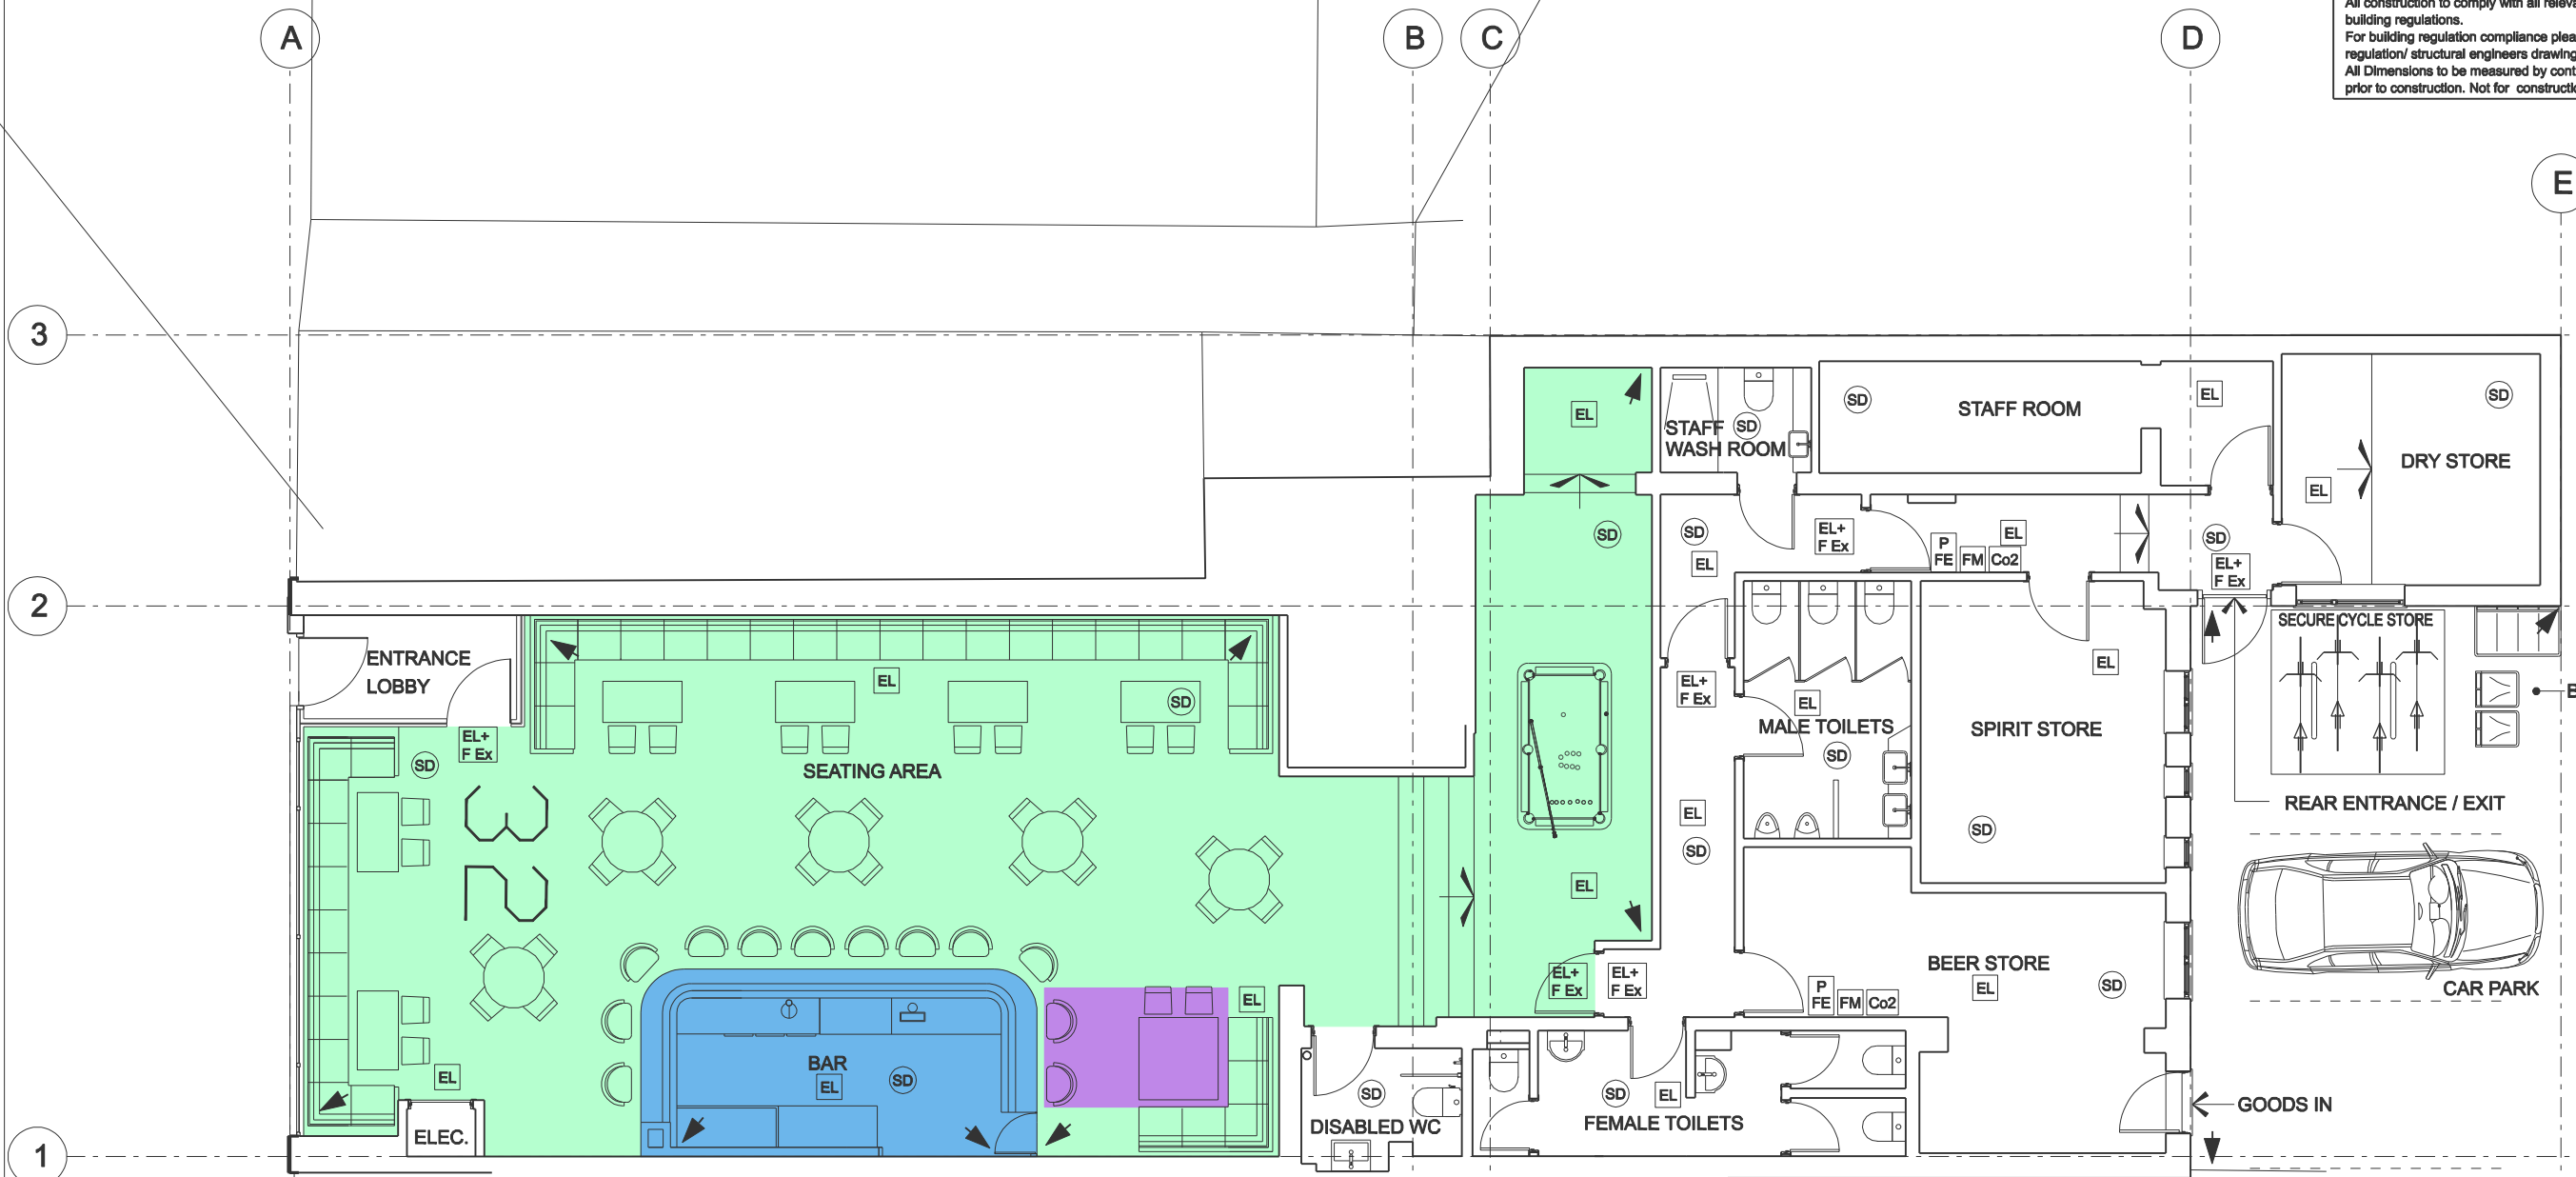

KEY:

- (SD) SMOKE DETECTOR
- (EL) EMERGENCY LIGHT
- (EL+ F Ex) CEILING MOUNTED EMERGENCY LIGHT WITH FIRE EXIT SIGN
- (FE) WALL MOUNTED FIRE EXTINGUISHER (WATER)
- (P FE) WALL MOUNTED FIRE EXTINGUISHER (POWDER)
- (FM) WALL MOUNTED FIRE EXTINGUISHER (FOAM)
- (Co2) WALL MOUNTED FIRE EXTINGUISHER (FOAM)
- (FB) WALL MOUNTED FIRE BLANKET
- ← SECURITY CAMERA
- SALE OF ALCOHOL
- CONSUMPTION OF ALCOHOL
- LOCATION OF OCASIONAL VOCALIST/ LIVE BAND

D1	09/07/2021	Planning
REV.	DATE	REASON FOR ISSUE
POWELL SKEETE ASSOCIATES ARCHITECTS & DEVELOPMENT CONSULTANTS		
17 Beechcroft Avenue Harrow HA2 7JD		
Project Address: 32 Bridge Street		
Pinner, HA5 3JF		
Project Number: PSA 2271		
Description: Change of Use from Bank to Drinking Establishment (Sui Generis)		
SCALE:	1:100@A3	CT1002A

01 PROPOSED GROUND FLOOR PLAN
 SCALE 1:100

