


KEY

- | | |
|---|-------------------|
|  | Smoke detector |
|  | Fire Extinguisher |
|  | Fire Exit |
|  | CCTV |
|  | Heat Detector |
|  | Fire Blanket |
|  | Fire Alarm Panel |
|  | Fire Alarm |
|  | Emergency Light |


ALARM SYSTEM TOAOISPEC OR SIMILAR FITTED

SHUTTER PROVIDED

CCTV MONITOR FOR MIN. 31 DAYS

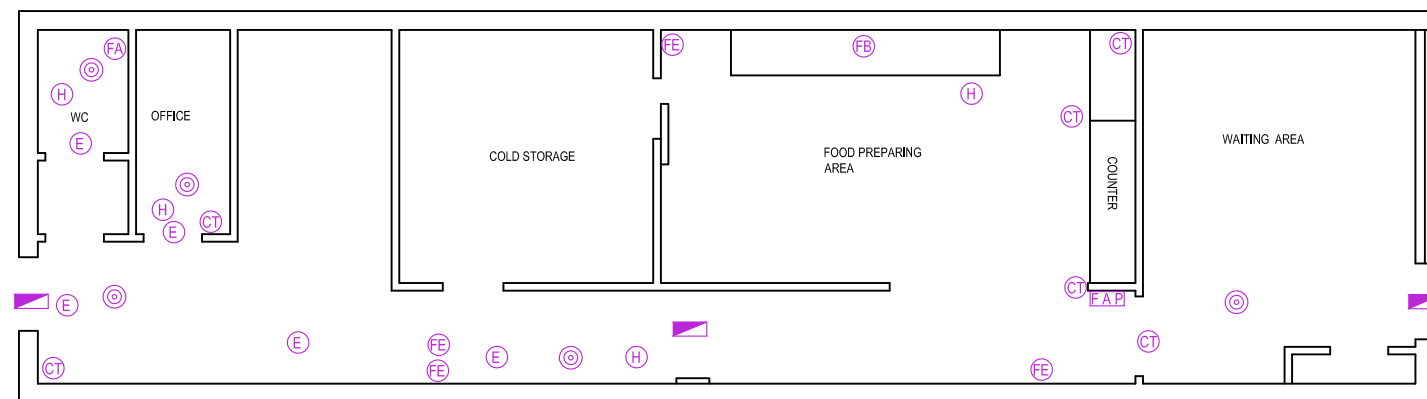

Existing Shop Floor Plan

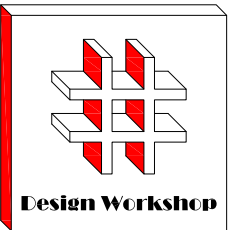

Dimensions to be verified on site
DO NOT SCALE FROM THIS DRAWING.
Any areas indicated on this drawing are for guidance
only.No responsibility is taken for their accuracy.

This drawing is the property of **Design Workshop Consultant Ltd**. Copyright is reserved by them and the drawing is issued on the condition that it is not copied, reproduced, retained or disclosed to any unauthorized person, either wholly or in part without the consent in writing of **Design Workshop Consultant Ltd**.

Site Address:

376 Station Road
Harrow
HA1 2DE

Title:

Licensing Plan

Scale:	1:100
--------	-------

Paper Size:	A3
-------------	----

Rev	Date	Comments
-----	------	----------

Drawn By: VP

Job Ref: 23033

Date: March 2023

Drawing No. PL - 01