


SERVICE ROAD

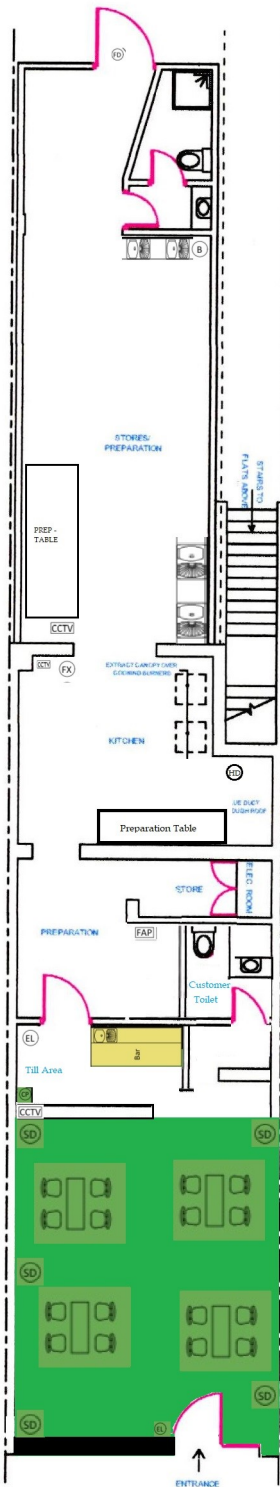

Note:

- (SD) = Smoke Detector
- (FD) = Fire Door
- (EL) = Emergency Light
- (HD) = Heat Detector
- (FAP) = Fire Alarm Panel
- (S) = Sounder
- (B) = Boiler
- (CCTV) = Camera
- (AC) = Air Con
- (FX) = Fire Extinguisher
- (CP) = Call Point
- [Yellow Box] = Alcohol Display Area
- [Green Box] = Alcohol Consumption Area

FOOTPATH



<b>FV CONSULTANT LTD.</b>		EXISTING & PROPOSED GROUND FLOOR PLAN			
DRAWN KM		DATE 06/19		401 KENTON LANE HARROW, HA3 8RZ	
CHECKED KM		SIZE A3	DWG NO. VC/163/PI/01	REV	
DESIGN KM		SCALE 1:100 @ A3	SHEET 01 OF 04		